

CONSTRUTION OF A 7  
BEDROOM HOUSE


NAME OF THE BUILDER :

OWNER'S NAME :

- 001 - LIST OF PAGES
- 002 - SITE PLAN
- 003 - SECTION A-A & B-B
- 004 - SECTION C-C & D-D
- 005 - SECTION E-E & F-F
- 006 - SECTION G-G & H-H
- 007 - SECTION I-I & J-J
- 008 - SECTION K-K - L-L
- 009 - SECTION M-M
- 010 - ELEVATION EAST & WEST
- 011 - ELEVATION SOUTH & NORTH
- 012 - FLOOR PLAN - GROUND FLOOR
- 013 - FLOOR PLAN - FIRST FLOOR
- 014 - SURFACE PLAN - GROUND FLOOR
- 015 - SURFACE PLAN - FIRST FLOOR
- 016 - ELETRIC PLAN - GROUND FLOOR
- 017 - ELECTRIC PLAN - FIRST FLOOR
- 018 - PLUMBING PLAN - GROUND FLOOR
- 019 - PLUMBING PLAN - FIRST FLOOR
- 020 - FOUNDATION PLAN
- 021 - SPECIFICATIONS OF WINDOWS

ELEVATION EAST & WEST

|             |  |                 |              |
|-------------|--|-----------------|--------------|
| Last name : |  | First name :    | Phone :      |
| Address :   |  | Date :          | Sheet number |
|             |  | Echelle: 1 : 40 | 010          |

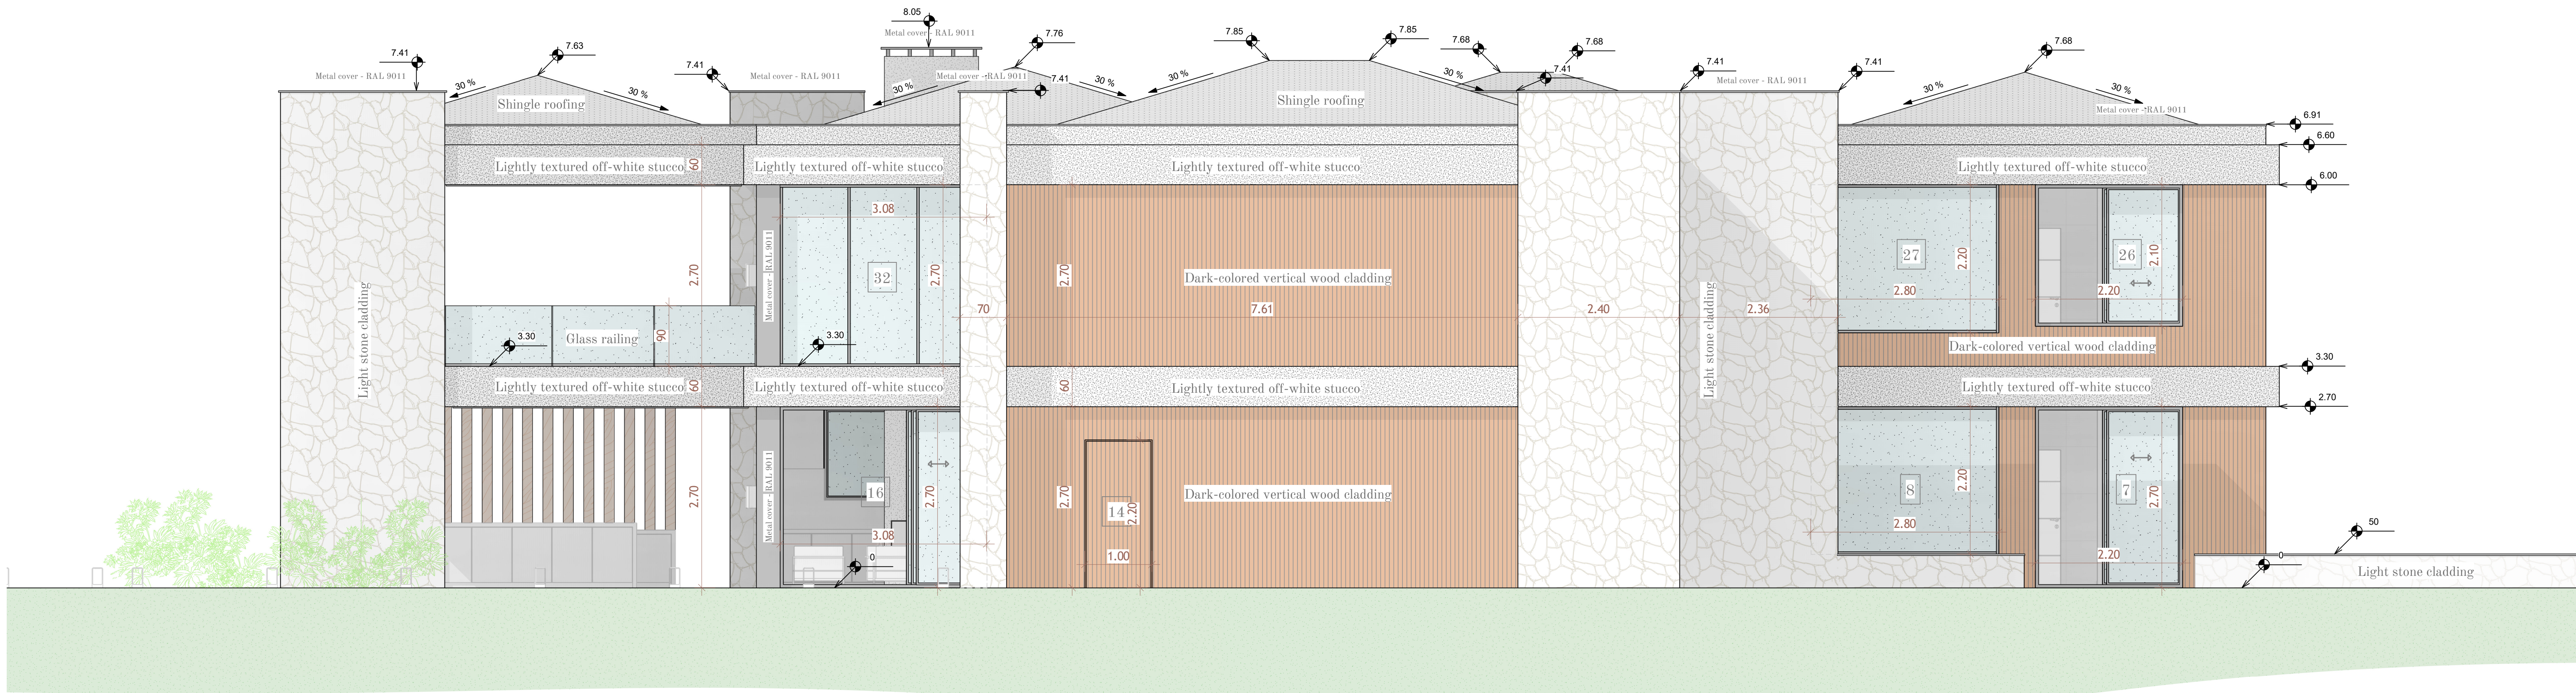

Elevation East



Elevation West