



All exterior windows will be aluminum, finished in RAL 9011.
The garage door and the technical room door will be concealed with the same cladding as the walls.
The front door will be aluminum, finished in RAL 9011 on the exterior side and wood-colored on the interior side.

Single casement window and doors

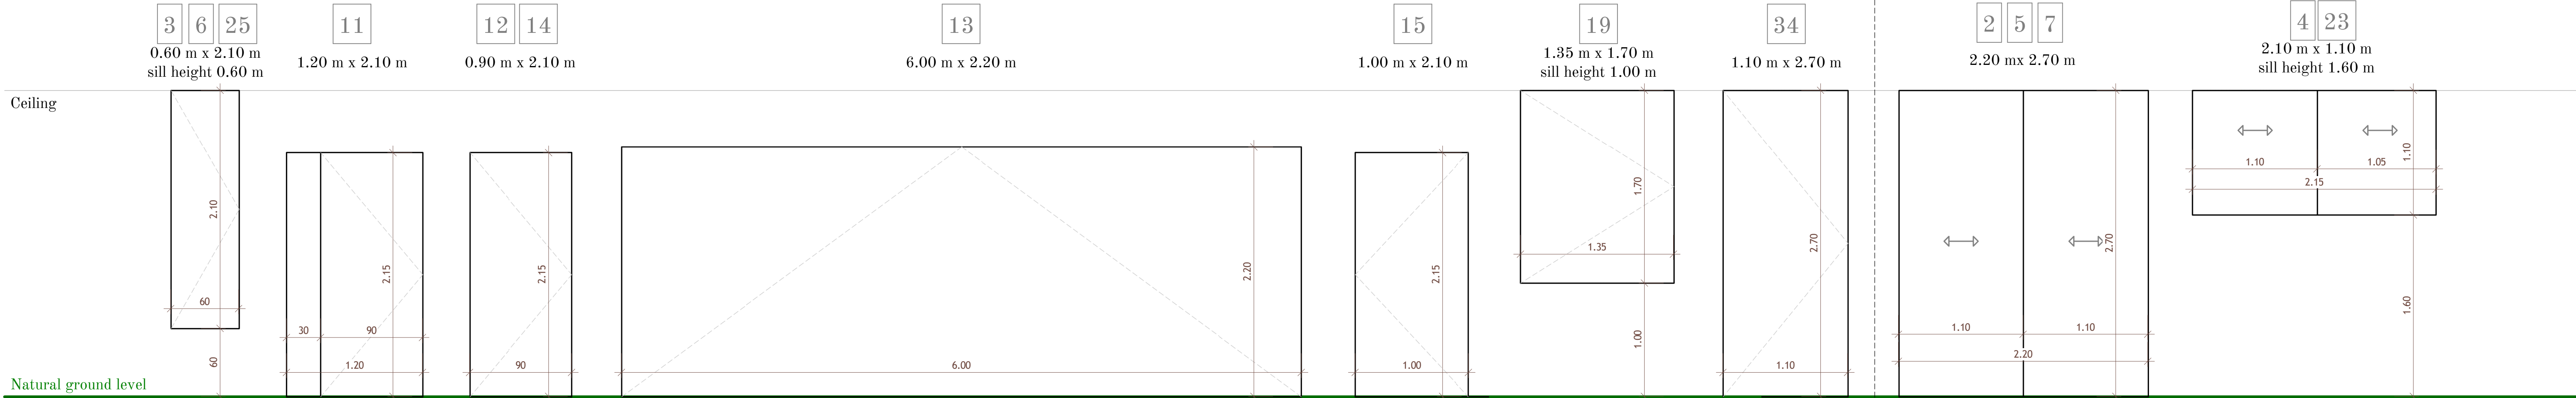


Two-panel sliding window

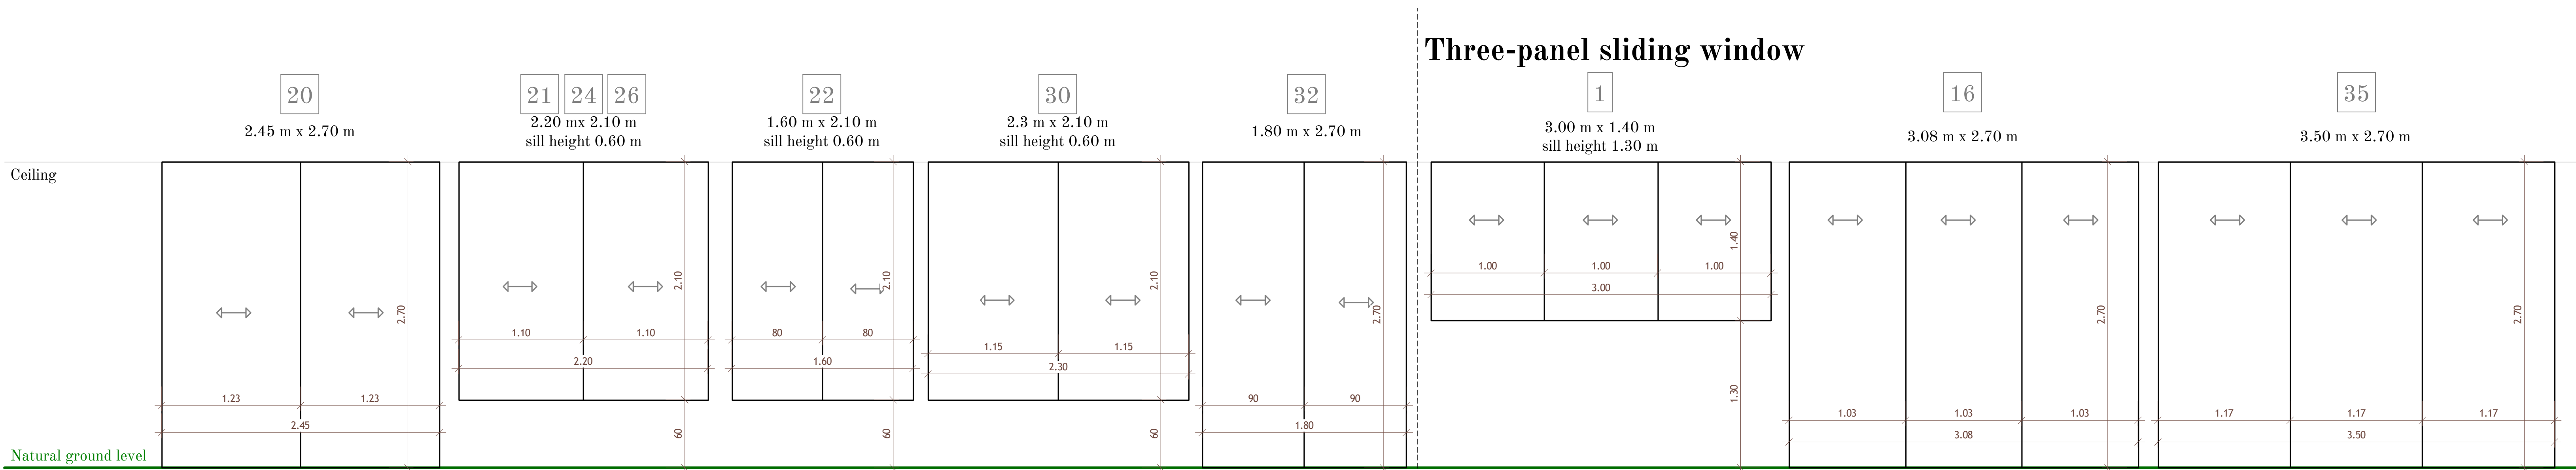


Three-panel sliding window

Fixed window

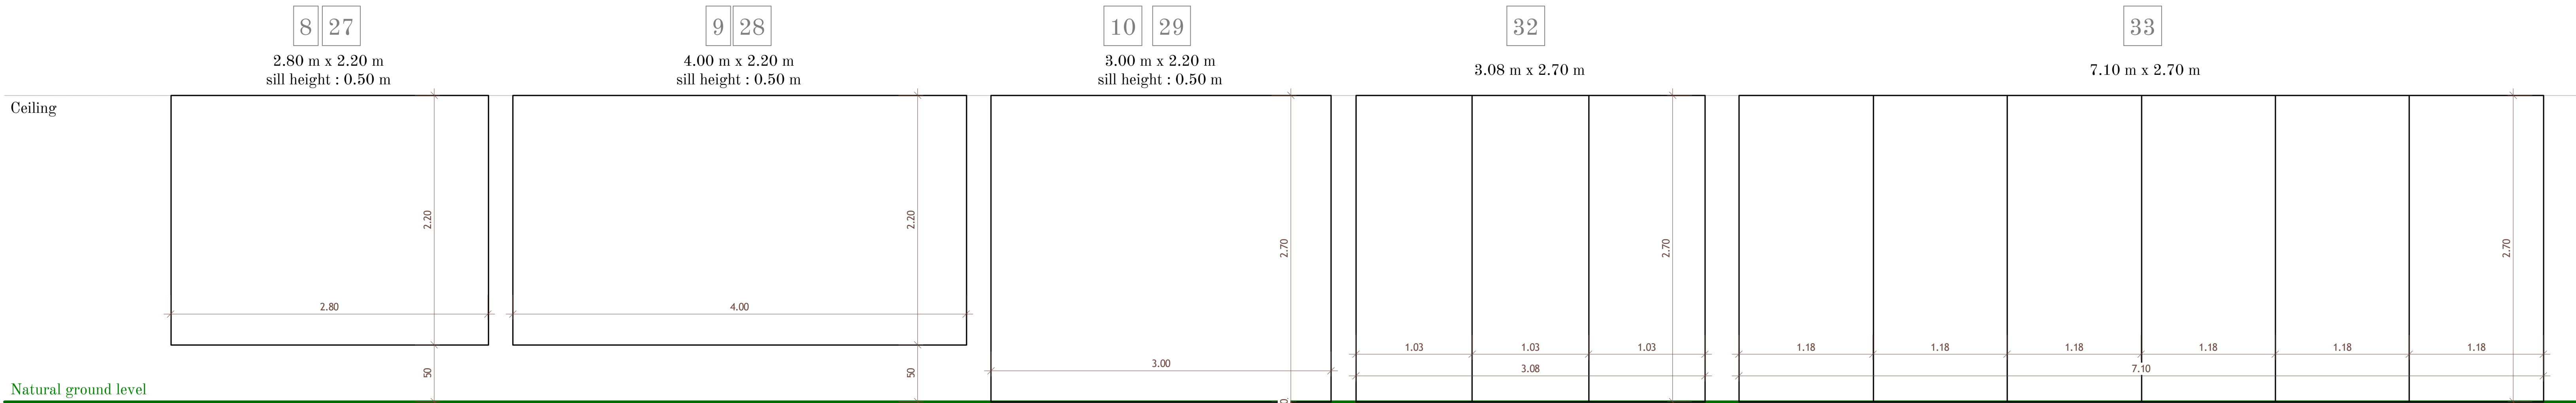

Six-panel sliding window

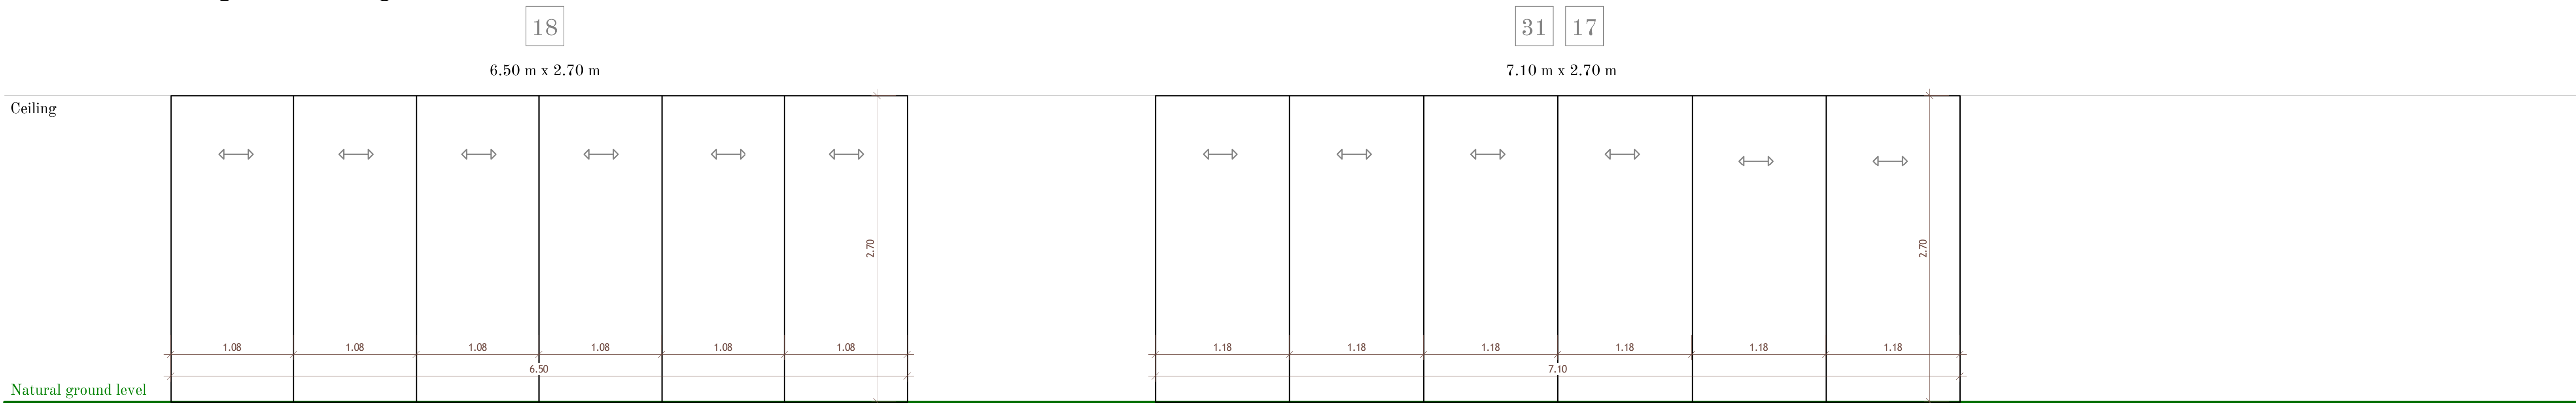

CONSTRUTION OF A 7
BEDROOM HOUSE

NAME OF THE BUILDER :

OWNER'S NAME :

- 001 - LIST OF PAGES
- 002 - SITE PLAN
- 003 - SECTION A-A & B-B
- 004 - SECTION C-C & D-D
- 005 - SECTION E-E & F-F
- 006 - SECTION G-G & H-H
- 007 - SECTION I-I & J-J
- 008 - SECTION K-K - L-L
- 009 - SECTION M-M
- 010 - ELEVATION EAST & WEST
- 011 - ELEVATION SOUTH & NORTH
- 012 - FLOOR PLAN - GROUND FLOOR
- 013 - FLOOR PLAN - FIRST FLOOR
- 014 - SURFACE PLAN - GROUND FLOOR
- 015 - SURFACE PLAN - FIRST FLOOR
- 016 - ELETRIC PLAN - GROUND FLOOR
- 017 - ELECTRIC PLAN - FIRST FLOOR
- 018 - PLUMBING PLAN - GROUND FLOOR
- 019 - PLUMBING PLAN - FIRST FLOOR
- 020 - FOUNDATION PLAN
- 021 - SPECIFICATIONS OF WINDOWS

SPECIFICATIONS OF EXTERIOR
WINDOWS AND DOORS

Some jurisdictions require a local architect or engineer to review and adapt the design to comply with local building codes and regulations. We strongly recommend checking with your local building department to confirm the applicable requirements. The sketch phase, preliminary design, and permit drawings cannot be used directly for construction. Implementation documents must be prepared at an appropriate scale. Schematic sections may be provided, but they cannot be used or applied without confirmation by a structural engineer. We recommend consulting your builder to produce detailed sections at the correct scale for construction. The project owner is also reminded of the obligation to carry out a soil study before starting any construction, and to comply with seismic and thermal regulations in force. Each construction project must be adapted to its site conditions and to the urban planning rules applicable in your municipality.

Last name :	First name :	Phone :
Address :	Date :	Sheet number
	Echelle: 1 : 24	021